

संदर्भ/Ref : CC-ENGG-CS201823-1000895-SE0138-OVERALL-LAYOUT

Date : 27/04/2021

From : Abhay Kumar
Senior GM

To : M/s GE T&D India Limited
A-18, First Floor, Okhla Industrial Area
Phase-II
New Delhi- 110020

Cc : GM (IB), CC-Gurgaon

Subject : Substation Package -SS01 for extension of 400(GIS)/220(AIS)kV Dhalkebar(NEA) Substation under Transmission system associated with Arun-3 HEP in Nepal

LOA Ref : CC-CS/921-CC/GIS-3967/3/G7 Dated 31/08/2020

Please find enclosed following drawings/ documents for necessary action at your end.

Vendor Drg. No. : 5427PS121-DHL-400-SYD-SCI-S2020-GA-0001

Orgn. Drg. No. : CS201823-1000895-SE0138-OVERALL-LAYOUT

Revision No. : 04

Drg. Title : Dhalkebar S/S-400/220kV overall Electrical Layout Plan & Sectional Drawing

App. Category : CAT-I

Release Date : 27/04/2021


Scan to verify

Comments : Document found to be in order.


अनुमोदित श्रेणी/App. Category:

- I. फेब्रिकेशन/निर्माण/टाइप टेस्टिंग हेतु जारी।
Approved/released for fabrication/construction.
- II. फेब्रिकेशन/निर्माण/टाइप टेस्टिंग हेतु अनुमोदित/जारी बशर्ते दिए गए टिप्पणियाँ एवं आशोधनों की सम्मिलित किया जाये। कृपया रिवाइज्ड दस्तावेज अनुमोदनार्थ प्रस्तुत करें।
Approved/released for fabrication/ construction subject to incorporation of comments and modification as noted. Revised drawing required for approval.
- III. टिप्पणियाँ सम्मिलित करने के उपरांत दस्तावेज को अनुमोदनार्थ प्रस्तुत करें।
To be resubmitted for approval after incorporating the comments.
- IV. सूचनार्थ एवं रिकार्ड हेतु।
For information and record.
- REL-CON निर्माण हेतु जारी।
Released for construction.

नोट/Note:

1. Approval/Comments conveyed herein neither relieve the contractor of his contractual obligations and his responsibilities, weights, quantities, design details assemble fits, performance particulars and conformity of the supplies with the Indian Statutory Laws as may be applicable, nor does it limits the purchaser's right under the contract.
2. The approval conveyed vide this letter does not cover the approval of make for sub-vendor items.

This drawing and design is the property of < GE T&D INDIA > and must not be copied or lent without prior permission in writing

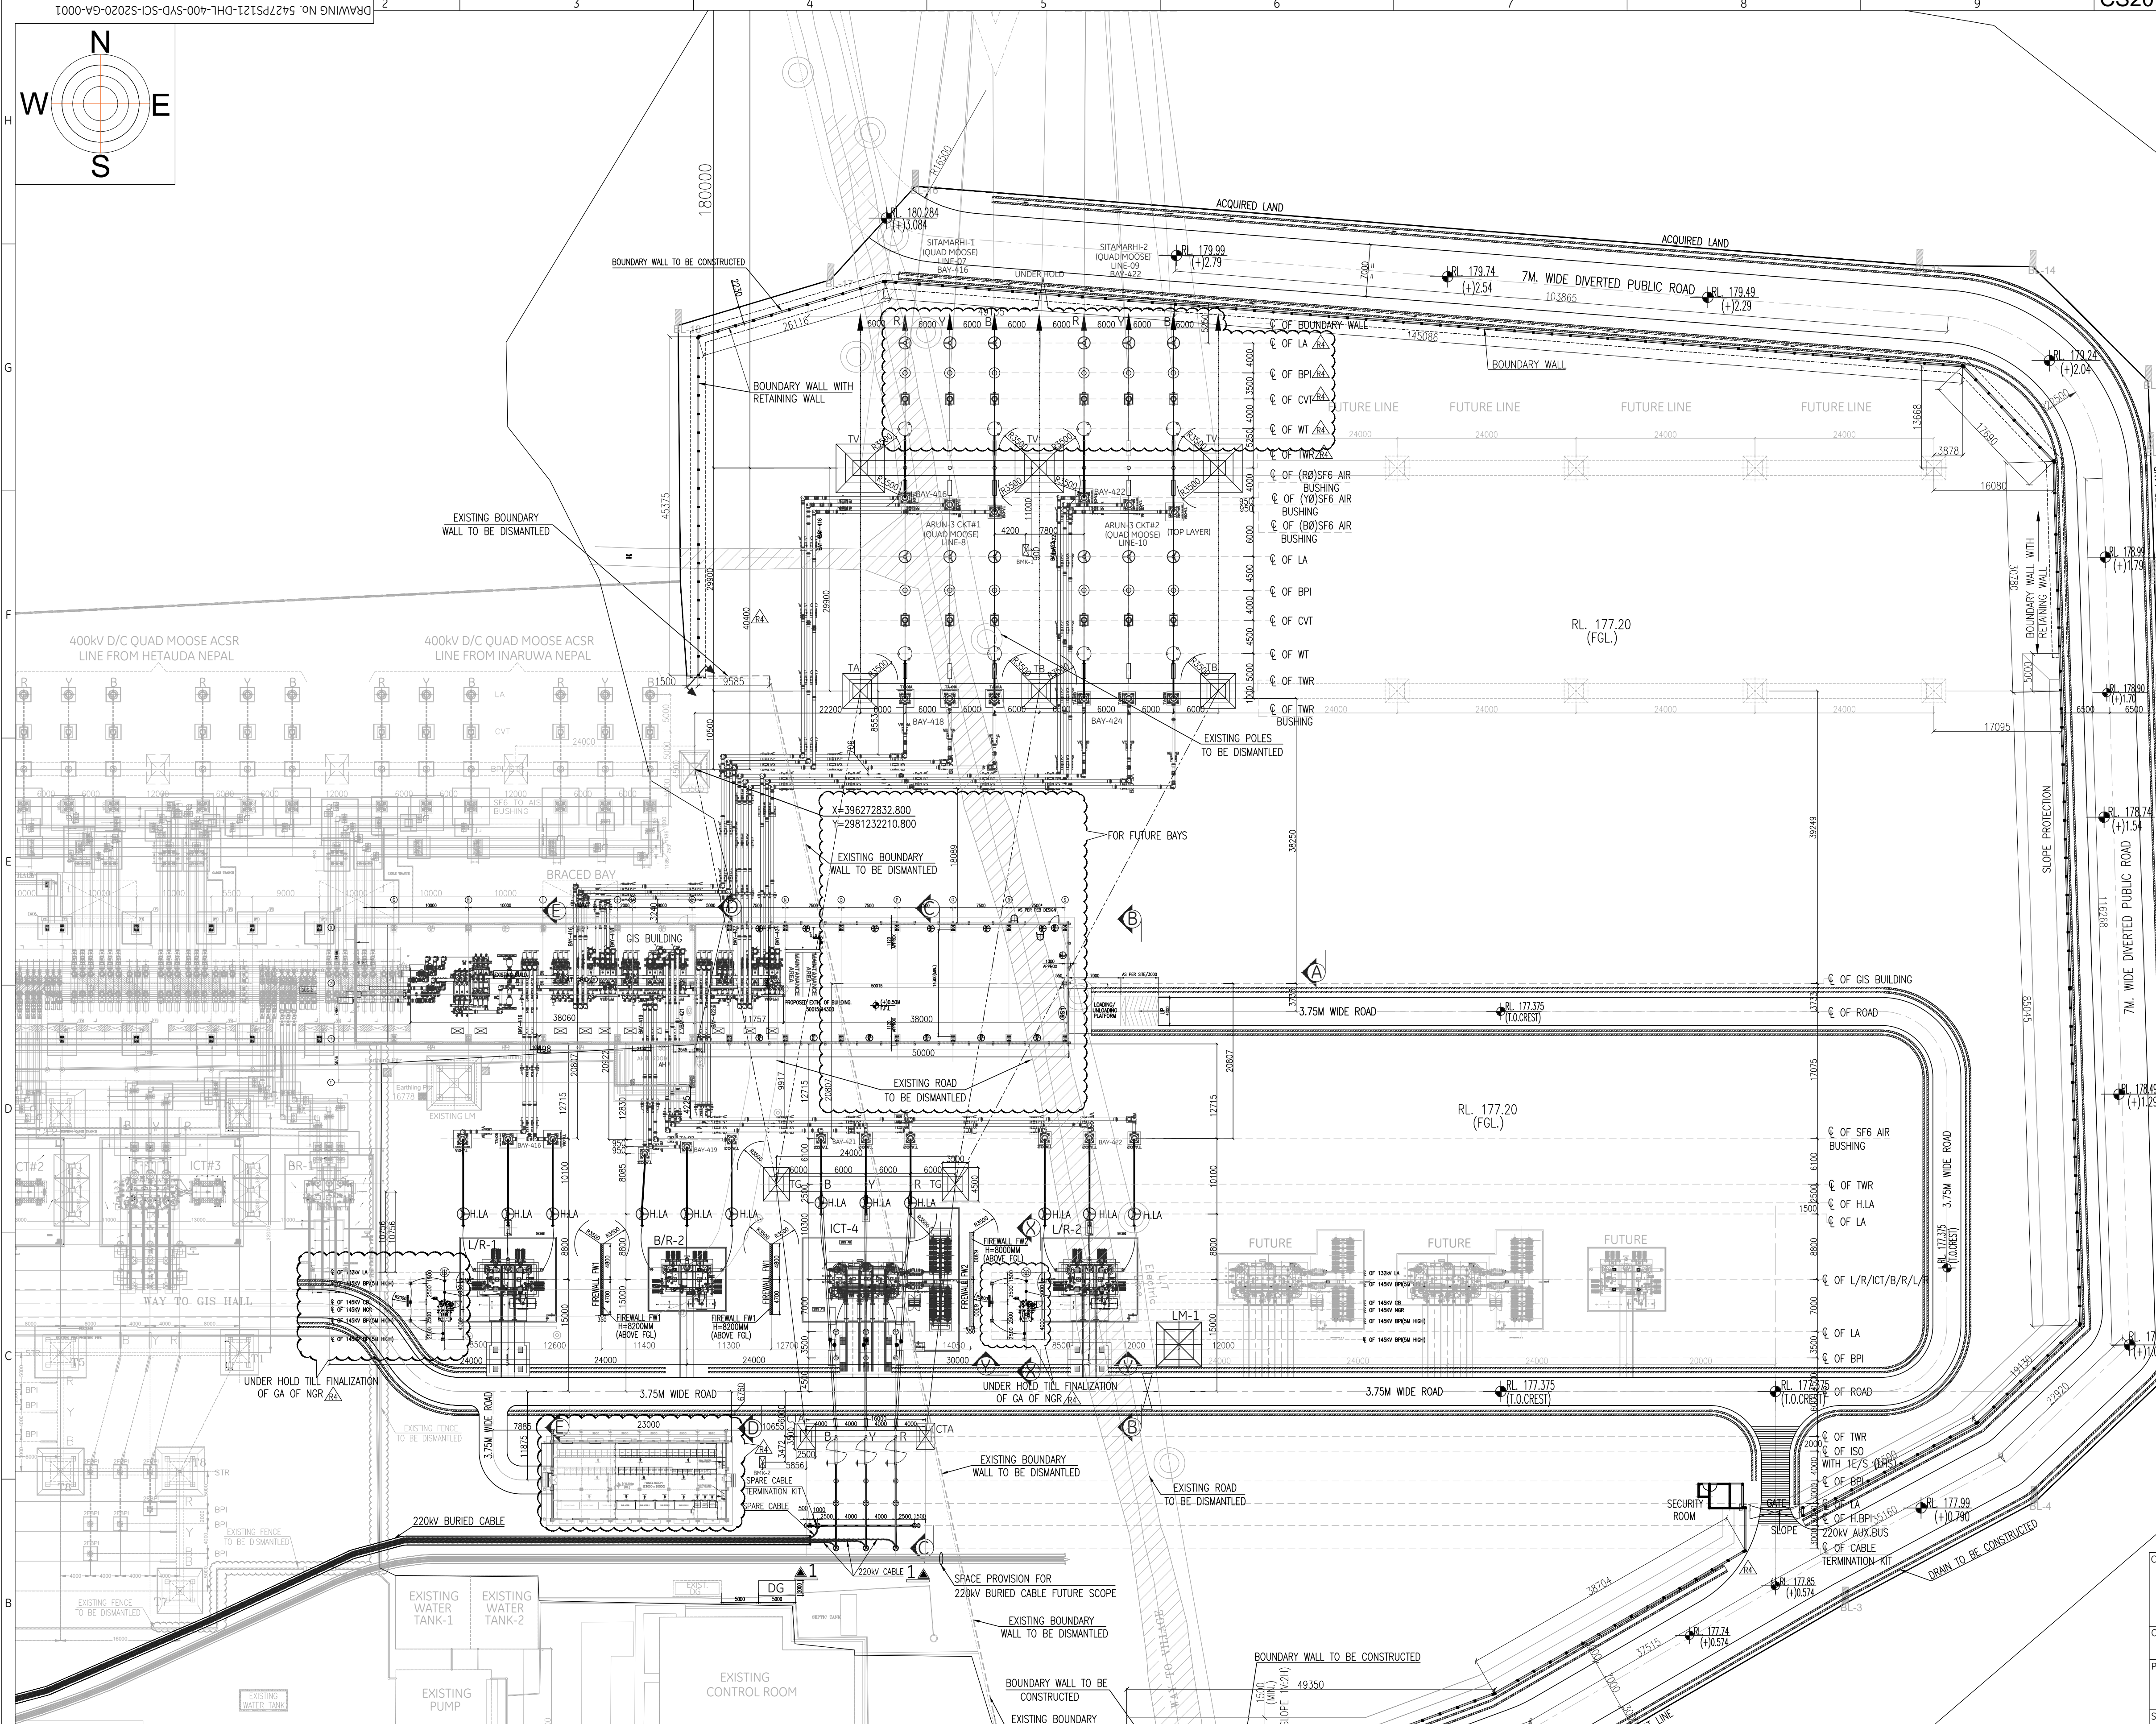

REFERENCE NO.	DESCRIPTION	LEGEND
1		
2		
3		
4		
5		
6		

REV.No.	DESCRIPTION	DATE	DRAWN	REVIEW	ELE.	CIVIL CHECKED	MECH.	APPROVED	STATUS
R4	REVISED AS PER PGCIL COMMENTS	19.04.21	19.04.21	19.04.21				19.04.21	FOR APPROVAL
R3	REVISED AS PER PGCIL COMMENTS	24.03.21	24.03.21	24.03.21				24.03.21	CAT-III
R2	REVISED AS PER PGCIL COMMENTS	29.01.21	29.01.21	29.01.21				29.01.21	CAT-II
R1	REVISED AS PER PGCIL COMMENTS	28.12.20	28.12.20	28.12.20				28.12.20	CAT-III
R0	FIRST ISSUE	03.12.20	03.12.20	03.12.20				03.12.20	CAT-III

CONSULTANT:



पावर ग्रीड कॉर्पोरेशन ऑफ इंडिया लिमिटेड
POWER GRID CORPORATION OF INDIA LIMITED
(A Government of India Enterprise)

OWNER:

SJVN ARUN-3 POWER DEVELOPMENT COMPANY PVT. LTD. (SAPDC)

PROJECT:

SUBSTATION PACKAGE- SS01 FOR EXTENSION OF 400(GIS/220(AIS) KV DHALKEBAR (INEA) GIS SUBSTATION TRANSMISSION SYSTEM ASSOCIATED WITH ARUN-3 HEP OF SJVN ARUN-3 POWER DEVELOPMENT COMPANY PVT.LTD. (SAPDC)

SUBSTATION:

EXTENSION OF 400(GIS/220(AIS) KV DHALKEBAR(INEA) S/S

CONTRACTOR:



GE T&D INDIA LTD.
T-5 & T-6, PLOT-I-14
AXIS HOUSE, JAYPEE WISHTOWN
SECTOR-128, NOIDA-201304
UTTAR PRADESH (INDIA)

NOA REFERENCE No.:

CC-CS/921-CC/GIS-3967/3/G7 Dated 31/08/2020

TITLE:

400/220KV OVERALL ELECTRICAL LAYOUT PLAN & SECTIONAL DRAWING

 
A1

DRAWING No.

TOTAL SH.
004

SH.No.

REV.





5427PS121-DHL-400-SVD-SCI-S2020-GA-0001

SCALE
1:450

002

R4

Range 1

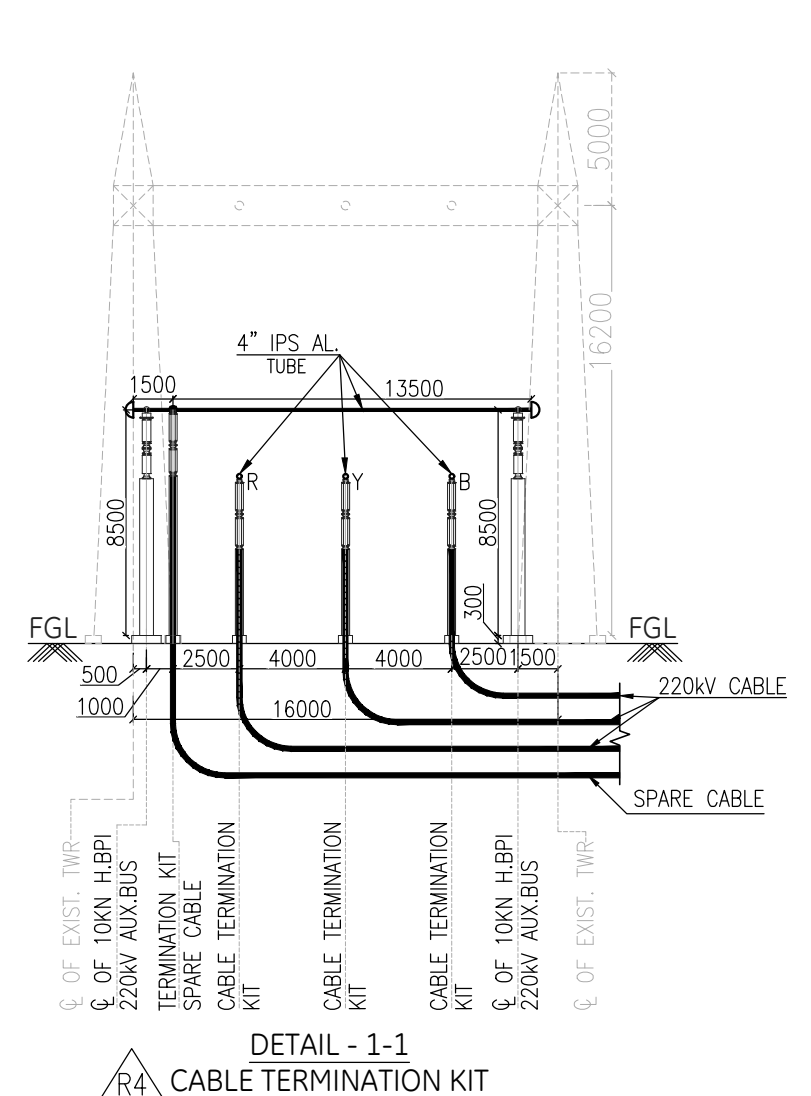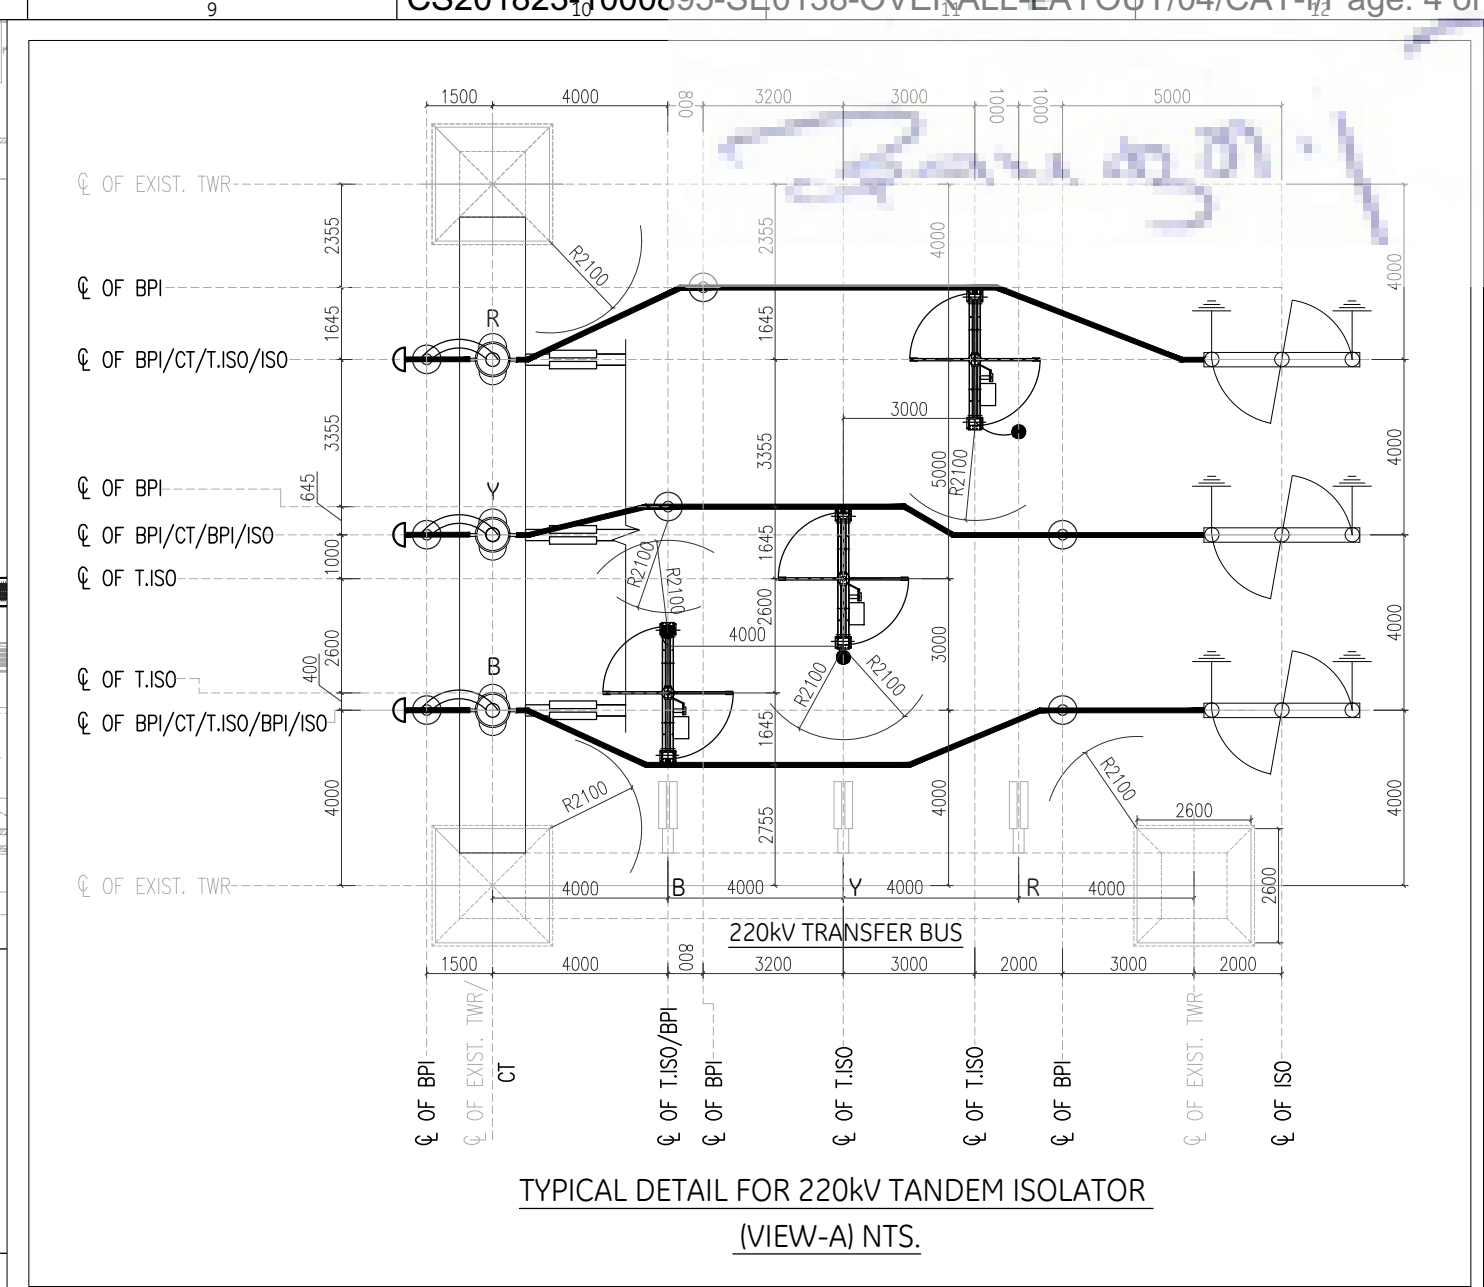

A	5427PS121-DHL-400-SYD-CHT-S2020-GA-0007 5427PS121-DHL-400-SYD-SCI-S5020-SL-0001 3VIN170650X1008 (Rev.02)	400kV GIS ARRANGEMENT LAYOUT PLAN & SECTION 400/220kV SWITCHYARD SINGLE LINE DIAGRAM 400/220kV DHALKEBAR GIS S/S OVERALL ELECTRICAL PLAN LAYOUT	LEGEND:- ———— PRESENT SCOPE ----- EXISTING SCOPE	R4	REVISED AS PER PGCIL COMMENTS	Name	PK	SS	BB			KNG	FOR APPROVAL		
				Date	19.04.21	19.04.21	19.04.21			19.04.21					
				Sign.											
				R3	REVISED AS PER PGCIL COMMENTS	Name	PK	SS	BB			KNG	CAT-III		
				Date	24.03.21	24.03.21	24.03.21			24.03.21					
				Sign.											
				R2	REVISED AS PER PGCIL COMMENTS	Name	PK	HMT	BB			KNG	CAT-II		
Date	29.01.21	29.01.21	29.01.21			29.01.21									
Sign.															
R1	REVISED AS PER PGCIL COMMENTS	Name	PK	HMT	BB			KNG	CAT-III						
Date	28.12.20	28.12.20	28.12.20			28.12.20									
Sign.															
R0	FIRST ISSUE	Name	PK	HMT	BB			KNG	CAT-III						
Date	03.12.20	03.12.20	03.12.20			03.12.20									
Sign.															
				REV.No.	DESCRIPTION	DATE	DRAWN	REVIEW	ELE.	CIVIL	MECH.	APPROVED	STATUS		
	REFERENCE NO.	DESCRIPTION	LEGEND												
	1	2	3	4	5	6	7	8	9	10	11	12			
											CONTRACTOR:  GE T&D INDIA LTD. T-5 & T-6, PLOT I-14 AXIS HOUSE, JAYPEE WISHTOWN SECTOR-128, NOIDA-201304 UTTAR PRADESH (INDIA)				
											NOA REFERENCE No: CC-CS/921-CC/GIS-3967/3/G7 Dated 31/08/2020				
											TITLE: 400/220kV OVERALL ELECTRICAL LAYOUT PLAN & SECTIONAL DRAWING				
											A1	DRAWING No.	TOTAL SH. 004	SH.No.	REV.
												5427PS121-DHL-400-SYD-SCI-S2020-GA-0001	SCALE 1:200	004	R4